


BRUCE STREET SOUTH

SEERVALE

CURB CUT

SEERVALE

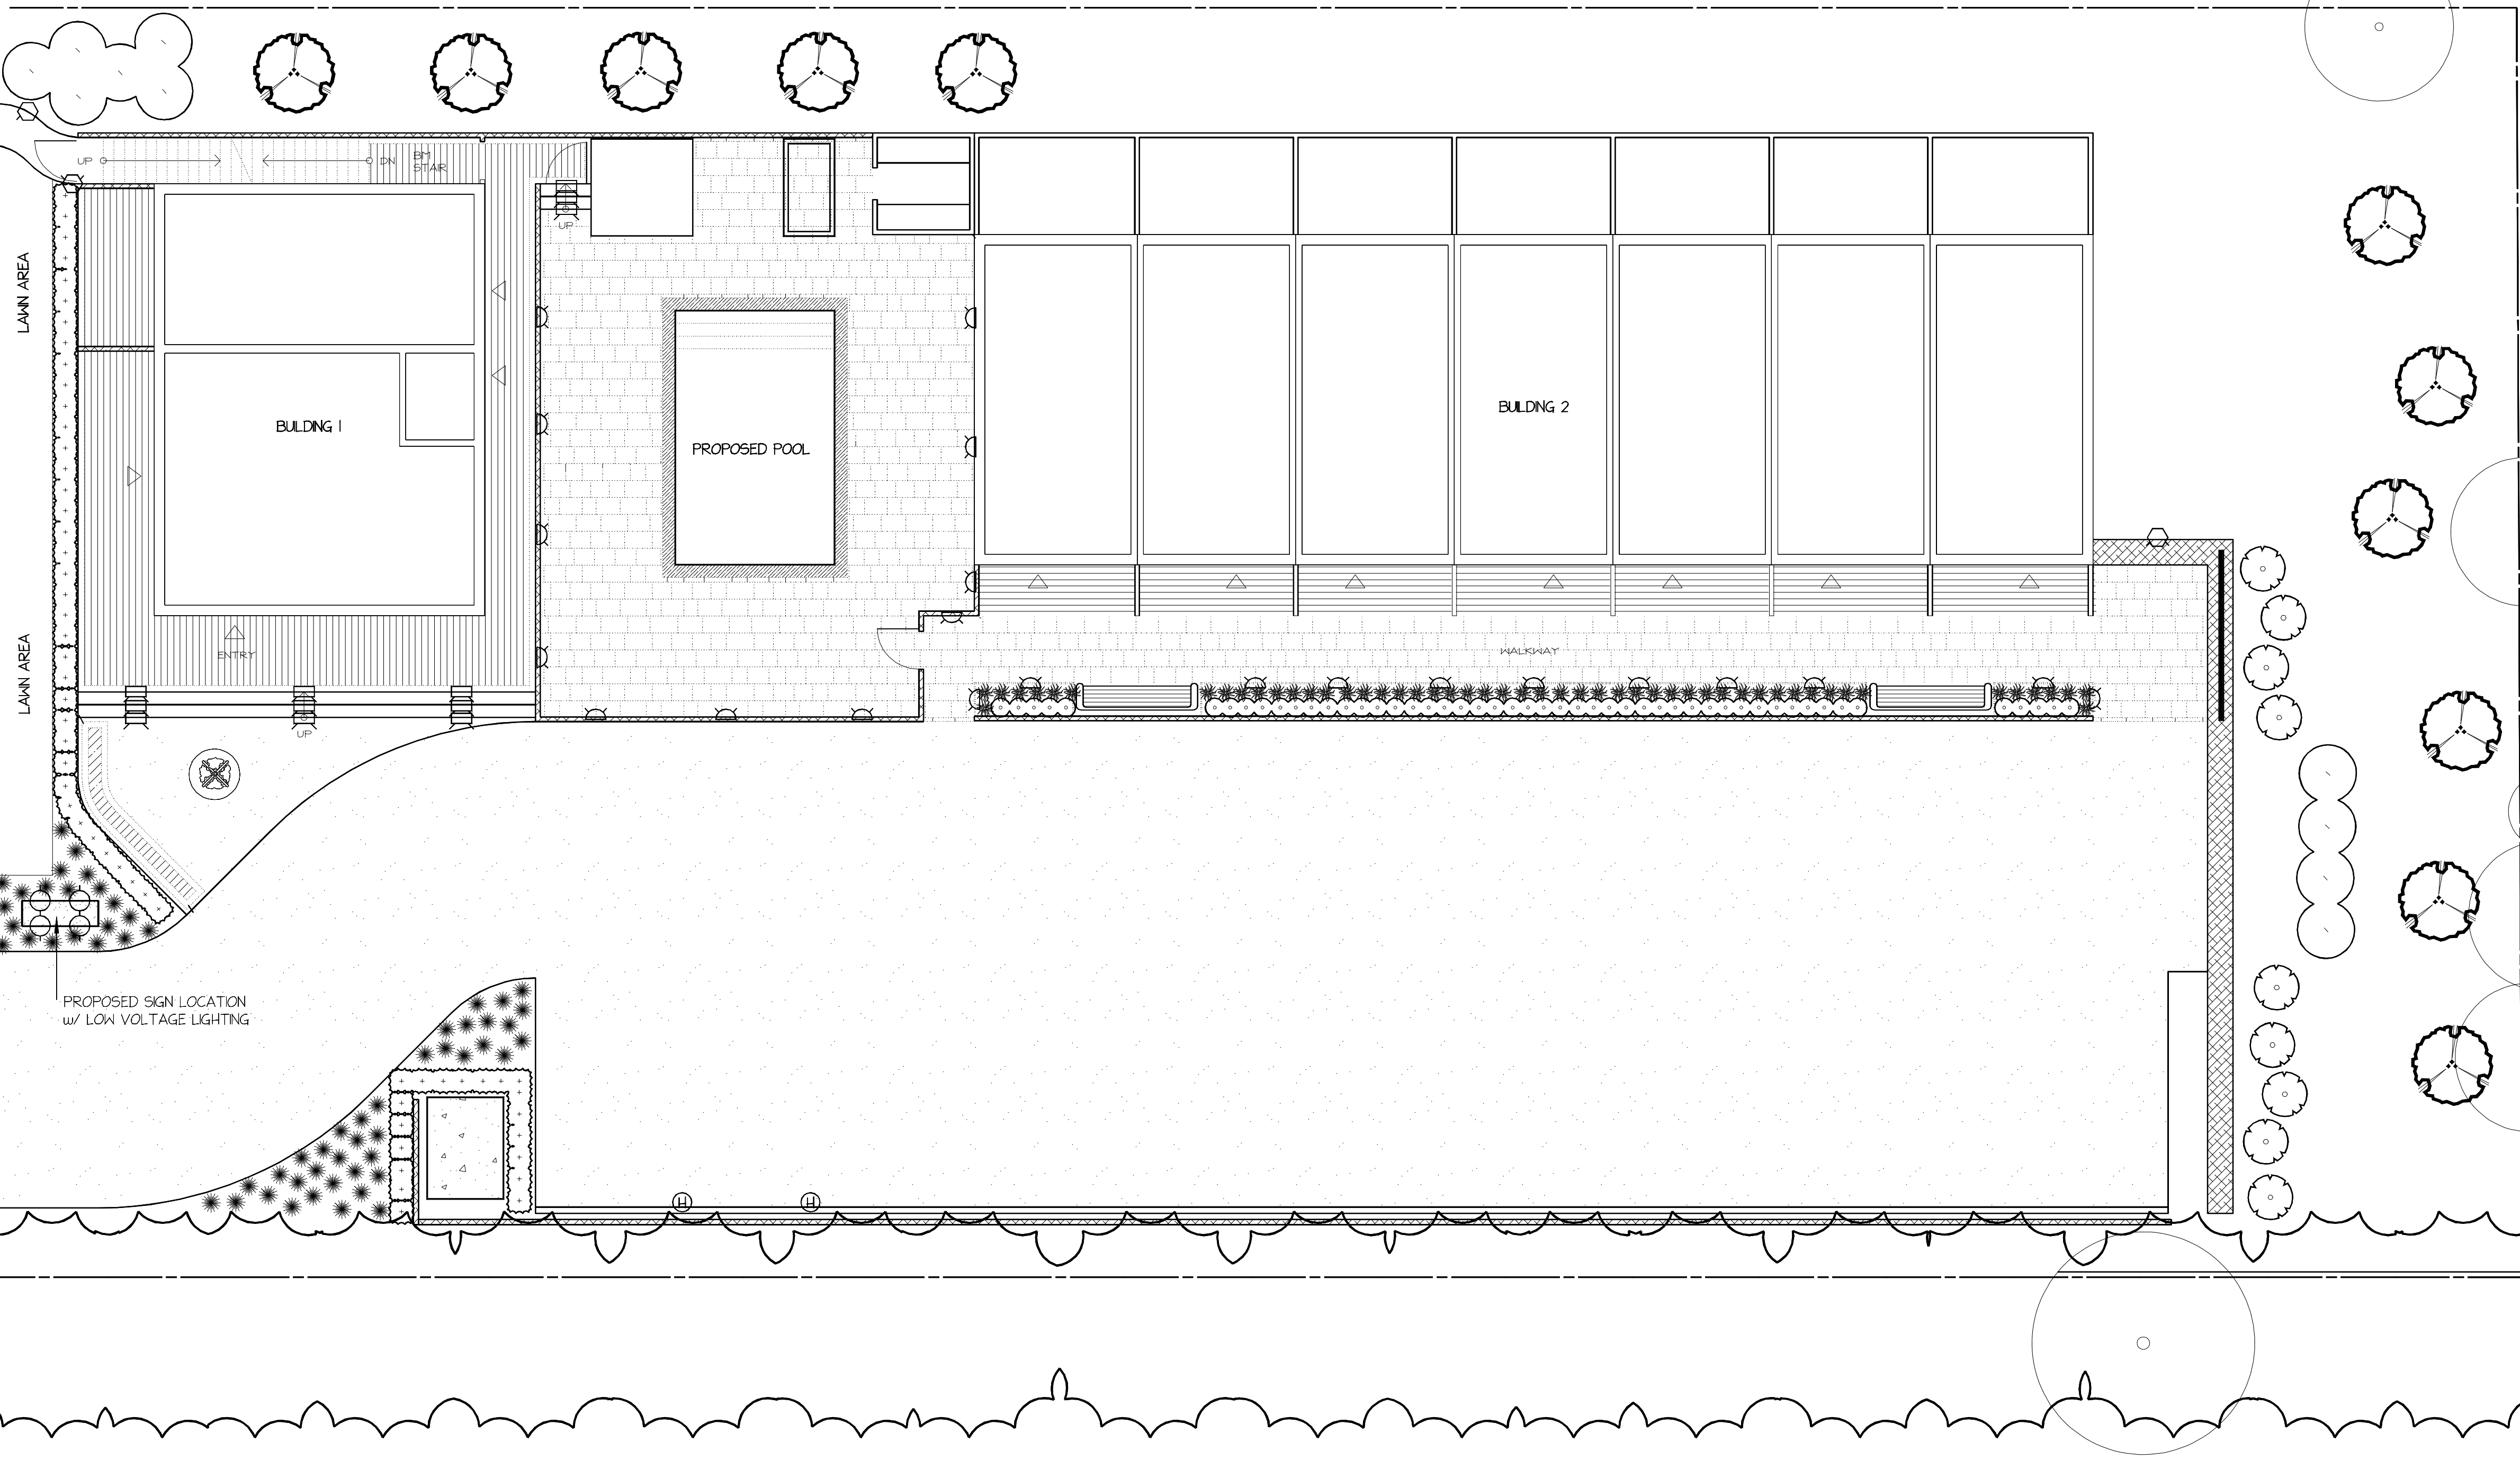

Landscape concept only. All proposed items such as structures, vehicles, walls, etc. are not shown in this drawing. The landscape concept is to be approved by the regulatory bodies prior to construction. The landscape concept is to be approved by the regulatory bodies prior to construction. It is the responsibility of the property owner to ensure that all proposed items are approved by the regulatory bodies prior to construction.

LIGHTING DETAIL



12V 3000K LED 12' Hardscope Textured Architectural Bronze



Linear Path Light 12V Landscape Path Luminaire Bronze 3000K



3000K LED Surface Mount Step Light Textured Architectural Bronze



VLO 3000K 12V LED 15'x15' Wall Wash Architectural Bronze

ALL LANDSCAPE LIGHTING TO BE LOW VOLTAGE 2400000V COPULANT

01	OCT	CON1 LIGHT
----	-----	------------

01	OCT	CON2 LIGHT
----	-----	------------

No.	Date	Description
REVISIONS		

53
BRUCE STREET S.
THORNBURY, ON



SCALE 1" = 8'

DRAWN BY JD

CHECKED BY MV

DATE OCT 2024

DATE OF PRINT

PROJECT NO.

CON2

SHEET NO.

LIGHTING PLAN(I)

LIGHTING CONCEPT